


DRAWING SCALE = 1/4" = 1'-0" (4X) SCALE FACTOR

RED = .007
 YELLOW = .013
 GREEN = .019
 CYAN = .015

BLUE = .025
 MAGENTA = .031
 WHITE = .037
 LIGHT-GRAY (A) = .043
 DARK-GRAY (A) = .051

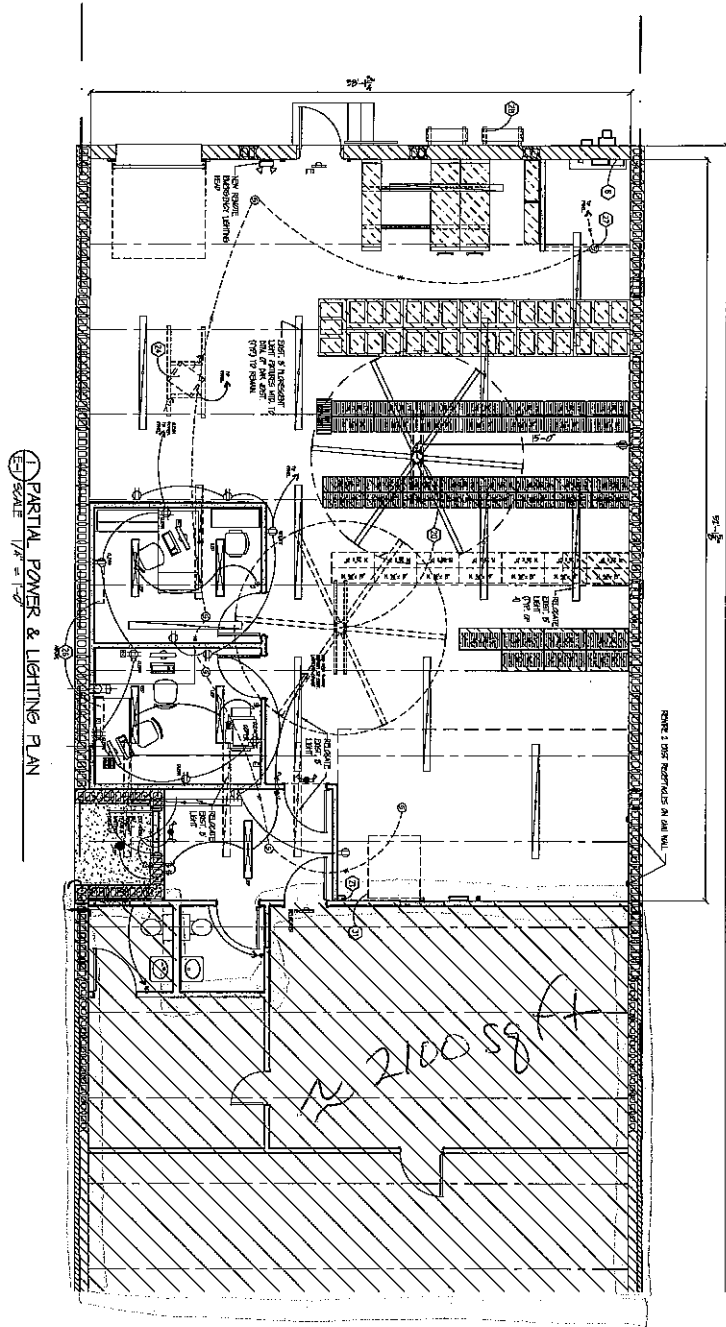

THIS PLAN REPRESENTS NEEDS OF OPERATION AND SOME
 SUGGESTIONS OF LOCATING THE LOWEST RESISTANCE PATH
 FOR ELECTRICAL ENERGY TO THE LOADS. IT DOES NOT
 SHOW THE COMPLETE INSTALLATION.

BUCKLEY HOLTEN ARCHITECTS LLC.
 ARCHITECTURAL AND INDUSTRIAL DESIGN
 Lexington, Kentucky
 (859) 277-1879
PARTIAL POWER/LIGHTING PLAN

BALLARD WRIGHT, MD., PSC.
 125 BURT RD. - MEDICAL RECORDS STORAGE
 2416 REGENCY ROAD
 LEXINGTON, KENTUCKY

DATE	1/15/11
REVISION	12/27/10
REV. DATE ISSUED	12/27/10
REV. DATE ISSUED	

REVISIONS
 1/15/11
 Drawn by: B. HOLTEN
 Approved by: K. HOLTEN
 Date: 1/12/11
 PROJECT NO. 090-13
 SHEET NO. E-1